

PROJECT : NO. 325 (PTR.)45

L'ORCHIDEE RESIDENCES

Location :
PATONG , PHUKET

Building :
VILLA TYPE WB

Owner :



A.C. HIGHLAND CO.,LTD.
13-0-004 P. PHRANGKAE ROAD PHUKA AREA PHUKET 81110

APPROVED BY :

MAIN CONTRACTOR :



POWER LINE
บริษัท เพาเวอร์ไลน์ เอ็นจิเนียริง จำกัด (มหาชน)
POWER LINE ENGINEERING PUBLIC CO., LTD.
13 ซอยสุขุมวิท 11 (ซอยสุขุมวิท 11) บางกะปิ กรุงเทพมหานคร 10210

Architect/Designer :
TOMARYK DESIGN CO.,LTD.

Structural Engineers :
BRANCH ASSOCIATES CO.,LTD.

Electrical Engineers :
POWER LINE ENGINEERING PUBLIC CO.,LTD.

Mechanical Engineers :
POWER LINE ENGINEERING PUBLIC CO.,LTD.

Sanitary Engineers :
POWER LINE ENGINEERING PUBLIC CO.,LTD.

Landscape Architect :
TOMARYK DESIGN CO.,LTD.

Interior Designer :
TOMARYK DESIGN CO.,LTD.

DRAWING

| | | | |
|--|--|--|--|
| | | | |
| | | | |
| | | | |
| | | | |

REVISIONS

| | | | |
|--------------|--|--|--|
| SHOP DRAWING | | | |
| | | | |
| | | | |

REVISIONS
AS - BUILT DRAWING

GENERAL NOTE

Drawing title :
LAY-OUT GROUND FLOOR PLAN
TYPE WB

| | |
|------------------------|------------|
| CHECK BY : J.PHEERAWAT | |
| DWG BY : | |
| DATE : | DWG. NO. : |
| SCALE : 1:150 | PLE-PTR-WB |
| APPROVED BY : ACH | AR-005 |
| TOTAL | |

L'ORCHIDEE RESIDENCES

Location :
PATONG , PHUKET

Building :
VILLA TYPE B2
BUILDING TYPE



APPROVED BY :

MAIN CONTRACTOR :



POWER LINE
บริษัท เพาเวอร์ไลน์ วิศวกรรม จำกัด (มหาชน)
POWER LINE ENGINEERING PUBLIC CO., LTD.
2 ซอยสุขุมวิท 41 (Ploenchit) แขวงคลองเตย เขตคลองเตย กรุงเทพฯ 10110
2 ซอยสุขุมวิท 41 (Sukhumvit 41) แขวงคลองเตย เขตคลองเตย กรุงเทพฯ 10110

Architect/Designer :

Structural Engineers :

Electrical Engineers :

Mechanical Engineers :

Sanitary Engineers :

Landscape Architect :

Interior Designer :

DRAWING

| REV.NO | DATE | DISCUSSION |
|--------|------|------------|
| - | - | - |
| - | - | - |
| - | - | - |
| - | - | - |

REVISIONS


GENERAL NOTE

Drawing title :

LOWER LEVEL PLAN (LAY-OUT PLAN)

TYPE B2

| | |
|------------------------|------------|
| CHECK BY: J. PHEERAWAT | DWG.NO. |
| DWG. BY: W. ISSARA | PLE-PTR-B2 |
| DATE: 9-03-06 | IN-001 |
| SCALE: 1:100 | |
| APPROVED BY: _____ | TOTAL |
| FILE NAME: _____ | |

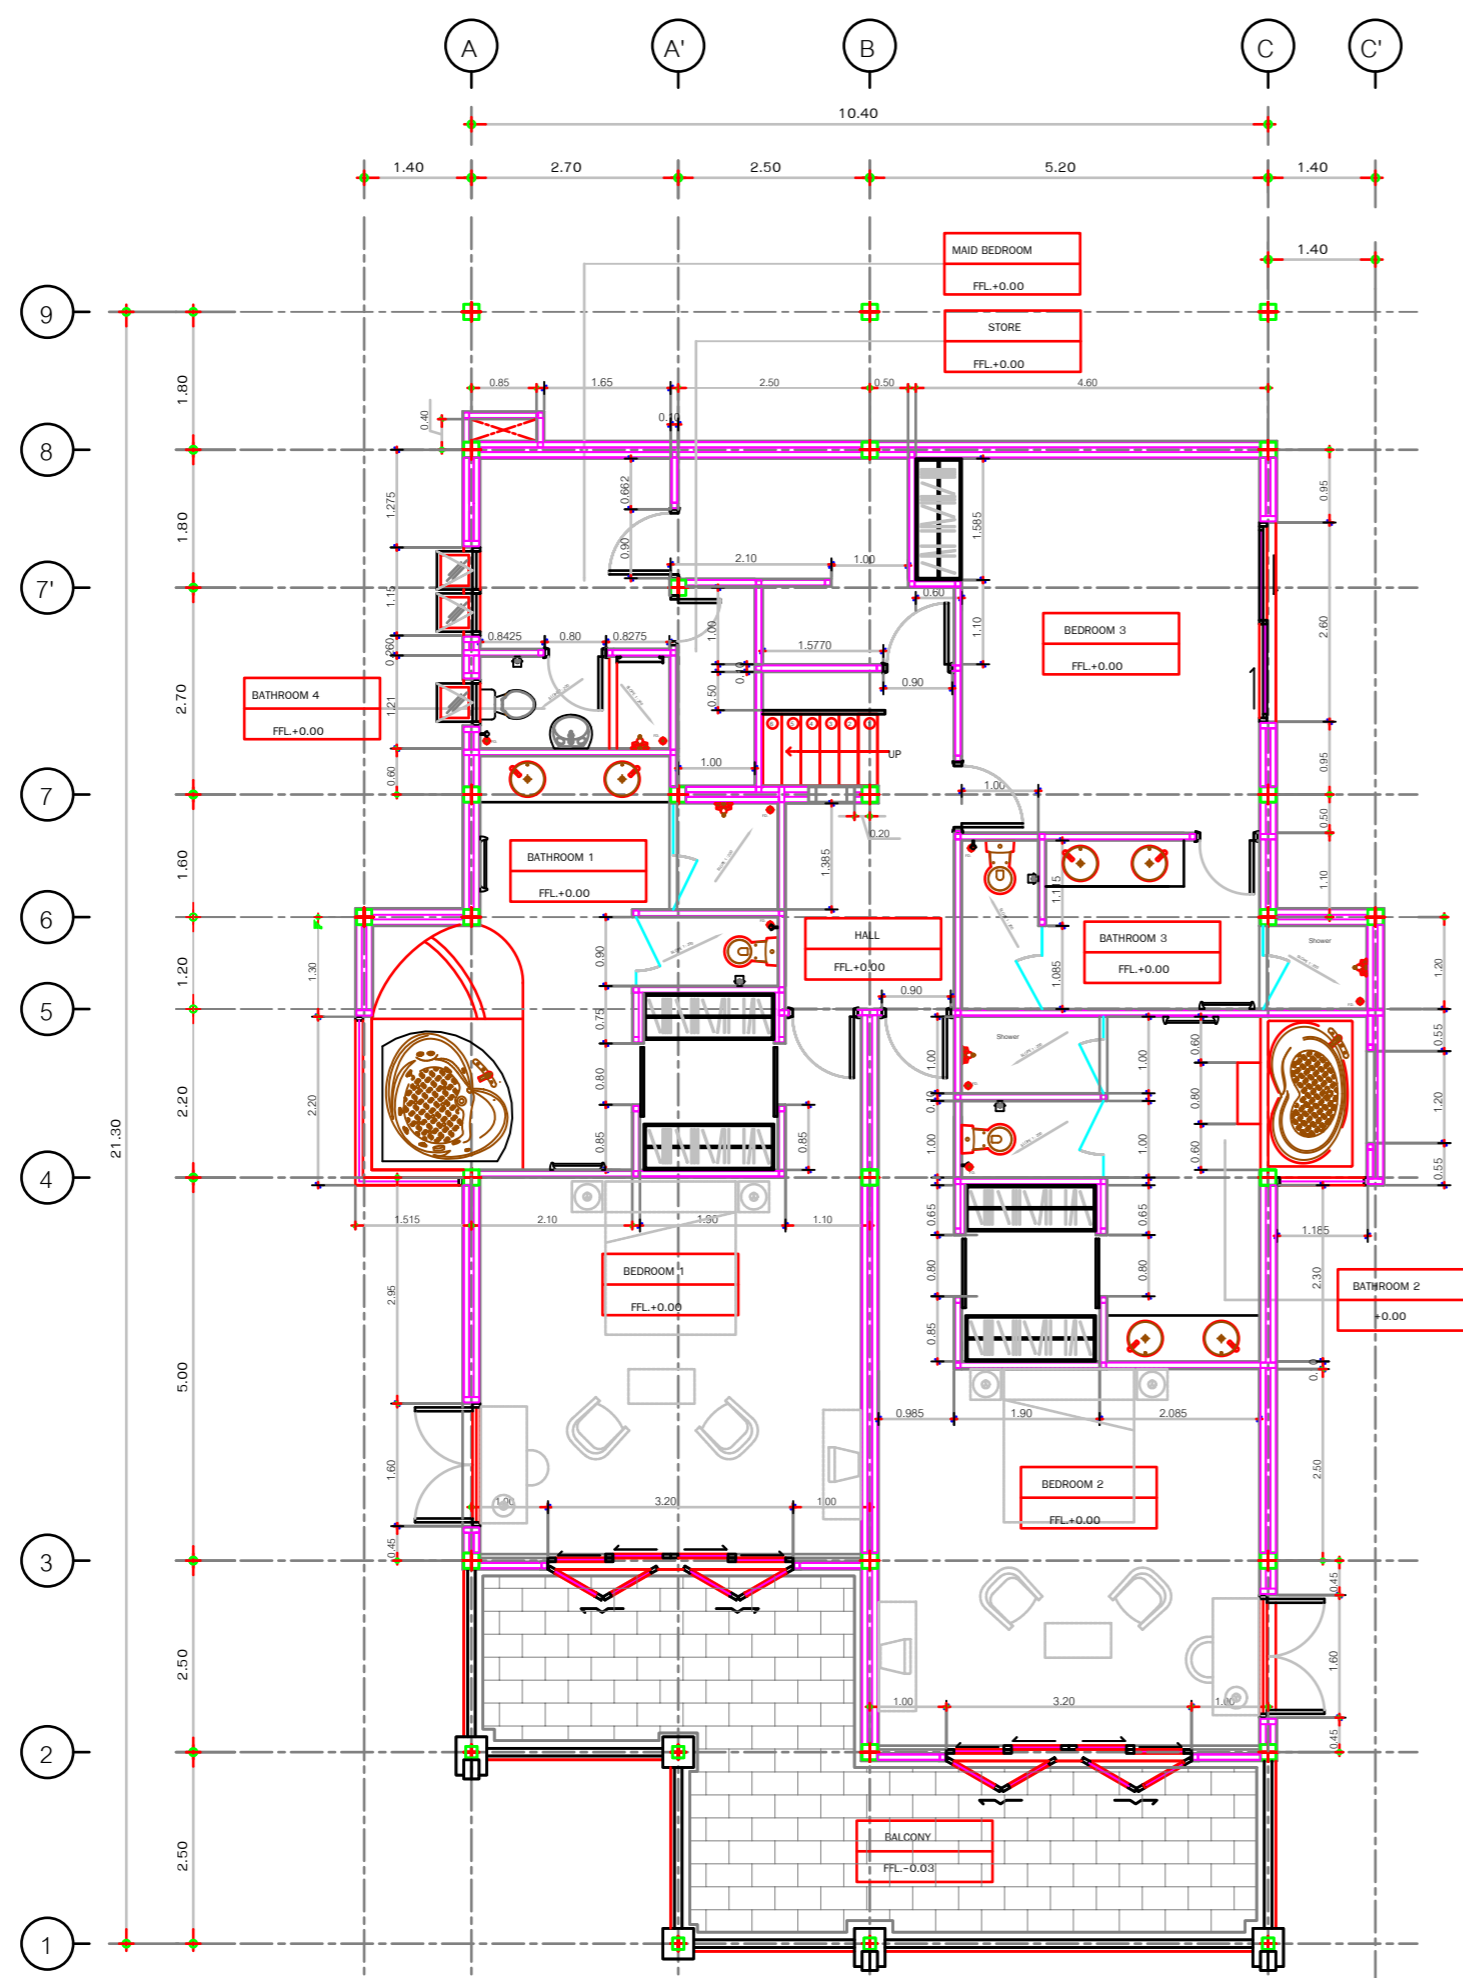

LOWER LEVEL PLAN (LAY-OUT PLAN)

SCALE 1 : 100

L'ORCHIDEE RESIDENCES


Location :
PATONG , PHUKET

Building :
VILLA TYPE B

Owner :

A.C. HIGHLAND CO.,LTD.
13/12 304 + PHIBUNROE ROAD PATONG NORTH PHUKET 83110
TEL. 075-2044441 FAX. 075-2414112
E-MAIL: aac@hIGHLAND.CO.LTD.

APPROVED BY :
MAIN CONTRACTOR :


POWER LINE
บริษัท สายงานวิศวกรรมไฟฟ้า จำกัด (มหาชน)
POWER LINE ENGINEERING PUBLIC CO., LTD.
2 หมู่ 10 ต. 10 (P.10) อ. ภูเก็ต จ. ภูเก็ต 83000
2 หมู่ 10 ต. 10 (P.10) อ. ภูเก็ต จ. ภูเก็ต 83000
TELEPHONE : (081) 311-0851
TEL. 075-204445 (11 Lines)

Architect/Designer :

Structural Engineers :

Electrical Engineers :

Mechanical Engineers :

Sanitary Engineers :

Landscape Architect :

Interior Designer :

DRAWING


| REV.NO | DATE | DISCRIPTION |
|--------|------|-------------|
| - | - | - |
| - | - | - |
| - | - | - |
| - | - | - |

REVISIONS
GENERAL NOTE

Drawing title :
B2 UPPER LEVEL PLAN (LAY-OUT PLAN)

TYPE B1 / B2

| | |
|-------------------------|----------------------|
| CHECK BY : J. PHEERAWAT | DWG.NO. PLE-PTR-B1B2 |
| DWG. BY : W. ISSARA | AR-020 |
| DATE : 2-03-06 | TOTAL |
| SCALE : 1:100 | |
| APPROVED BY : - | |
| FILE NAME : - | |

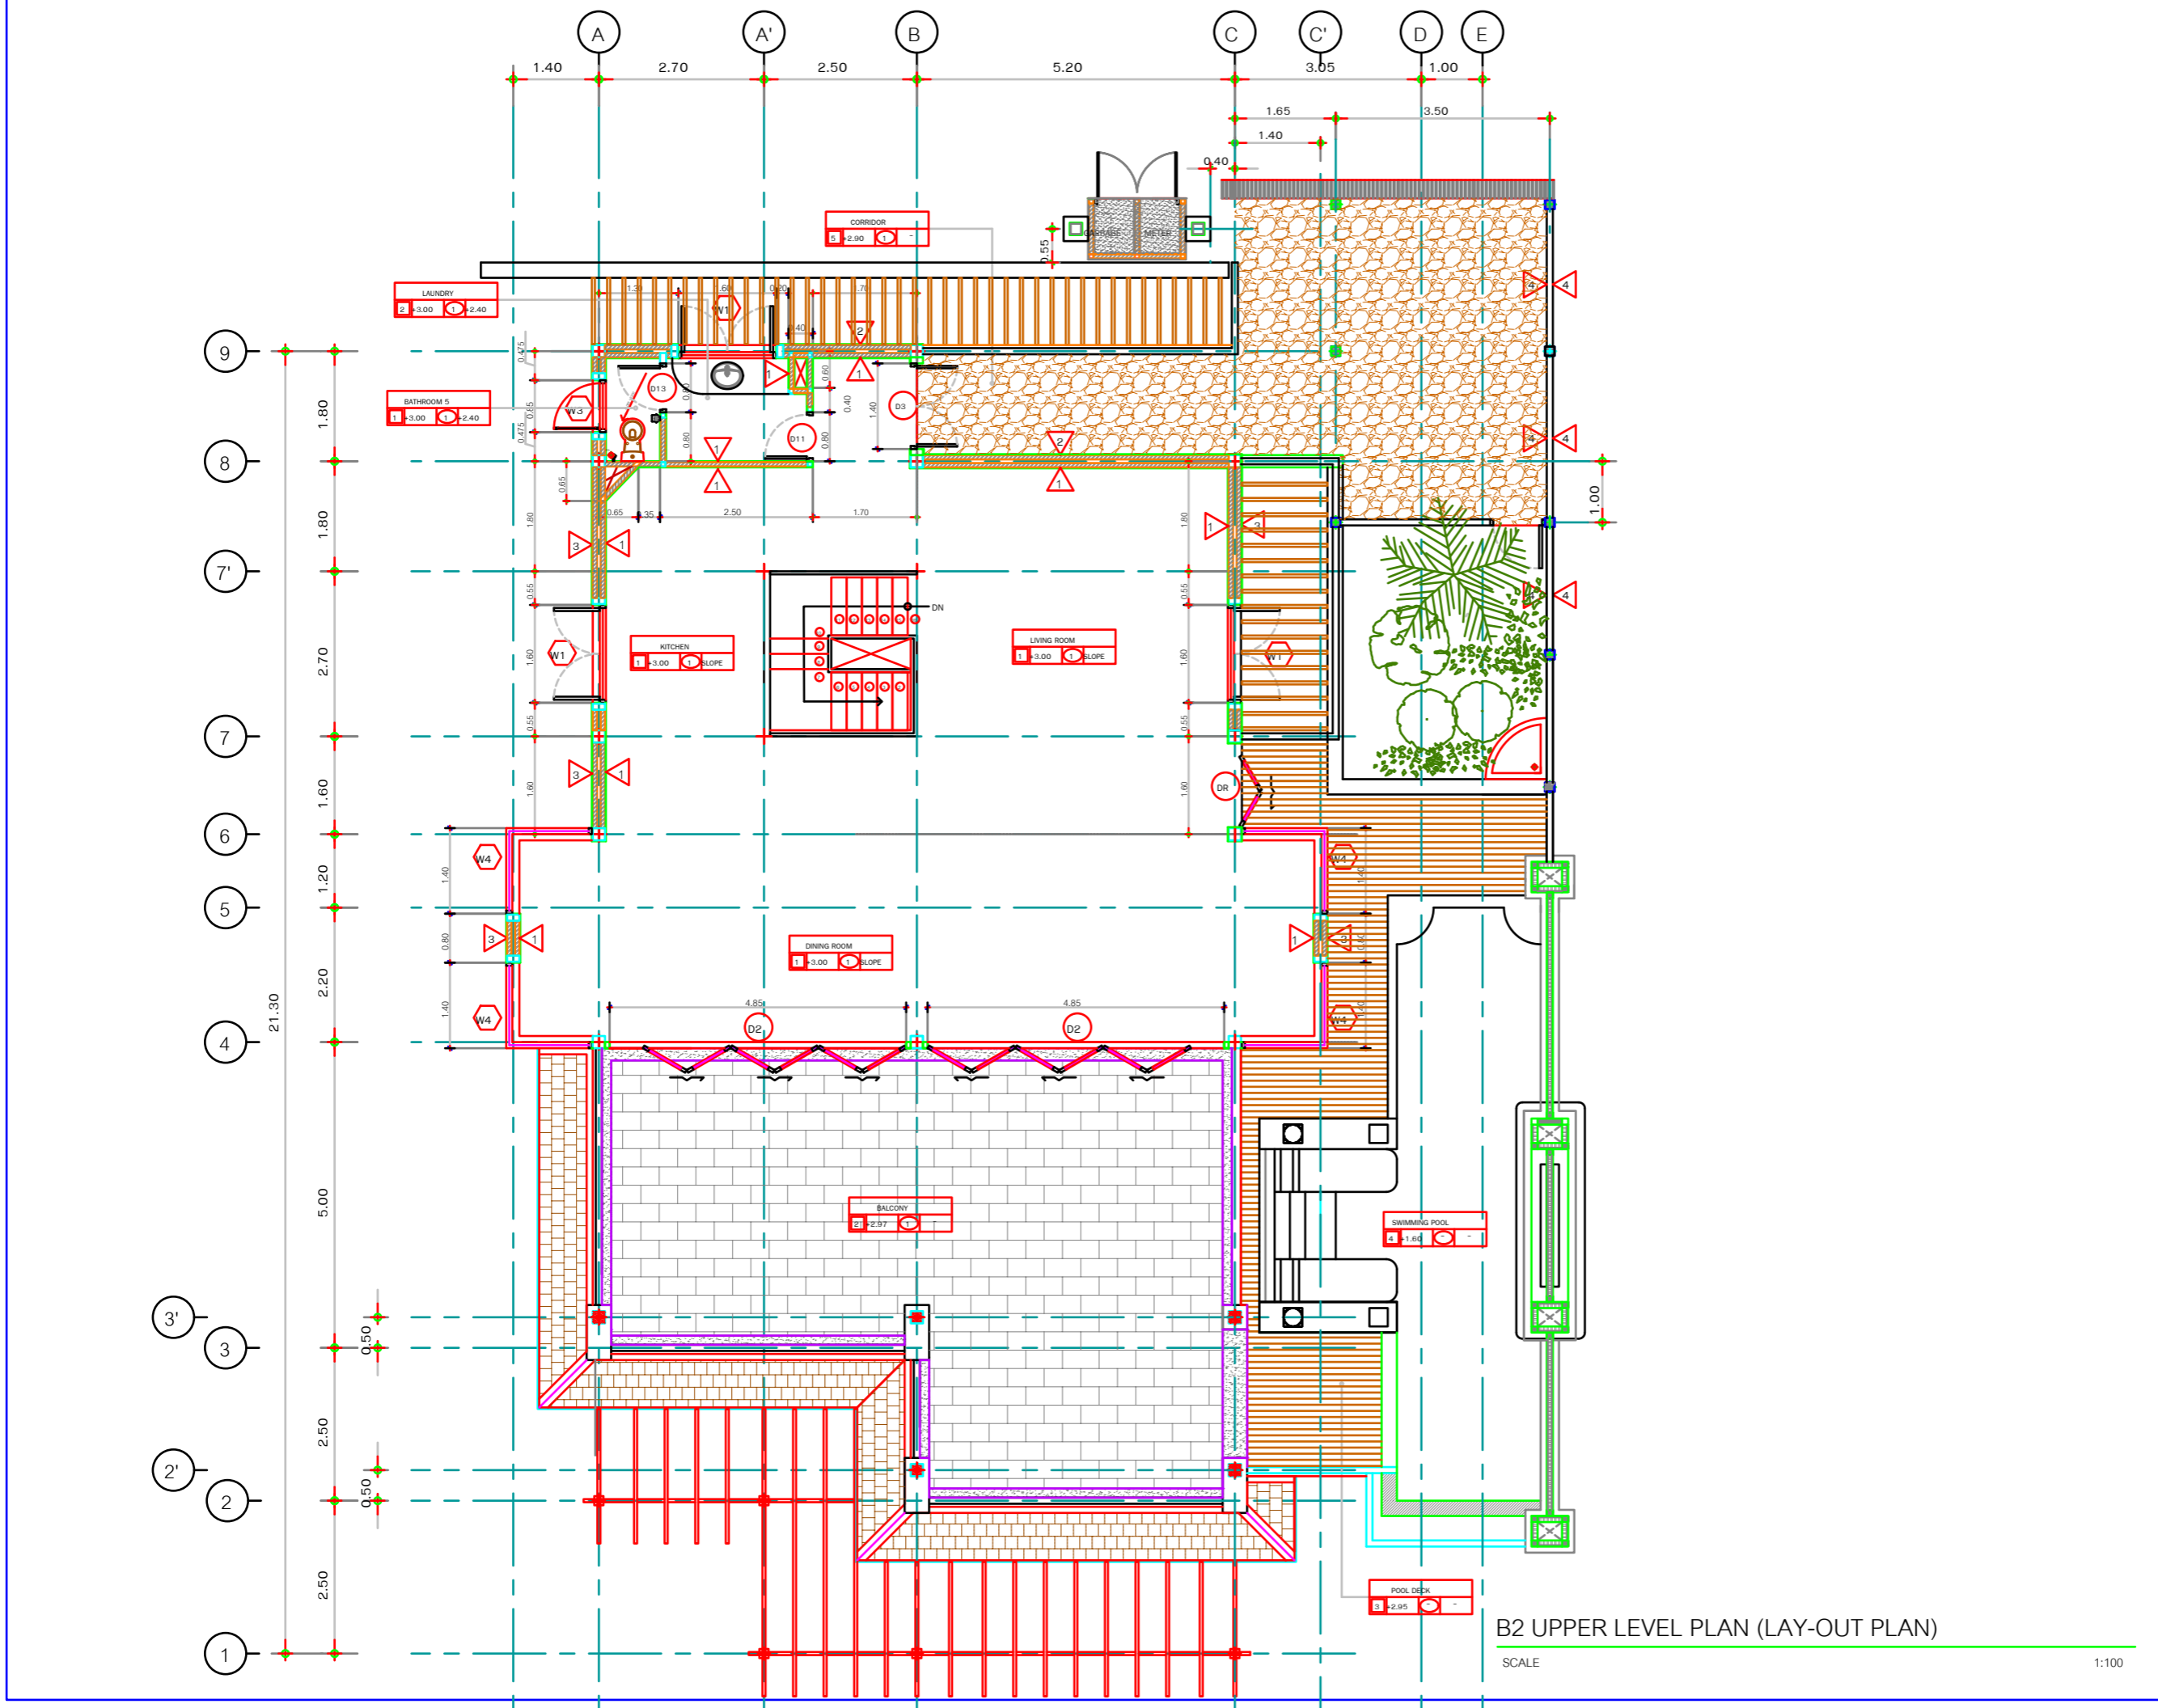

B2 UPPER LEVEL PLAN (LAY-OUT PLAN)

SCALE 1:100

L'ORCHIDEE RESIDENCES

Location :
PATONG , PHUKET

Building :
VILLA TYPE B

Owner : 
A.C. Highland Co., Ltd.
A.C. HIGHLAND CO., LTD.
13/100-4 PHEERAWAT ROAD PATONG PATONG PHUKET 80100
TEL. 075-554040-5 FAX 075-554112
E-MAIL : ach@achid.com

APPROVED BY :

MAIN CONTRACTOR :



POWER LINE
บริษัท พาวเวอร์ไลน์เอ็นจิเนียริ่งแอนด์คอนสตรัคชั่น จำกัด (มหาชน)
POWER LINE ENGINEERING PUBLIC CO., LTD.
2 หมู่ 8 ต. 10 (Pheewat) อ. ภูเก็ต จ. ภูเก็ต โทร. 075-554112
2 หมู่ 8 ต. 10 (Pheewat) อ. ภูเก็ต จ. ภูเก็ต โทร. 075-554112
REGISTRATION NO. (0002) 31 1-0001
TEL. 075-554112 (15 Lines)

Architect/Designer :

Structural Engineers :

Electrical Engineers :

Mechanical Engineers :

Sanitary Engineers :

Landscape Architect :

Interior Designer :

DRAWING

| | | |
|---|---|---|
| - | - | - |
| - | - | - |
| - | - | - |
| - | - | - |
| - | - | - |

| REVNO | DATE | DISCUSSION |
|-------|------|------------|
| | | |

REVISIONS


GENERAL NOTE

Drawing title :

ELEVATION 1

TYPE B1 /B2

| | | | |
|---------------|--------------|---------|--------------|
| CHECK BY : | J. PHEERAWAT | DWG.NO. | |
| DWG BY : | W. ISSARA | | PLE-PTR-B1B2 |
| DATE : | 2-03-06 | | AR-007 |
| SCALE : | 1:125 | | |
| APPROVED BY : | - | TOTAL | |
| FILE NAME : | - | | |

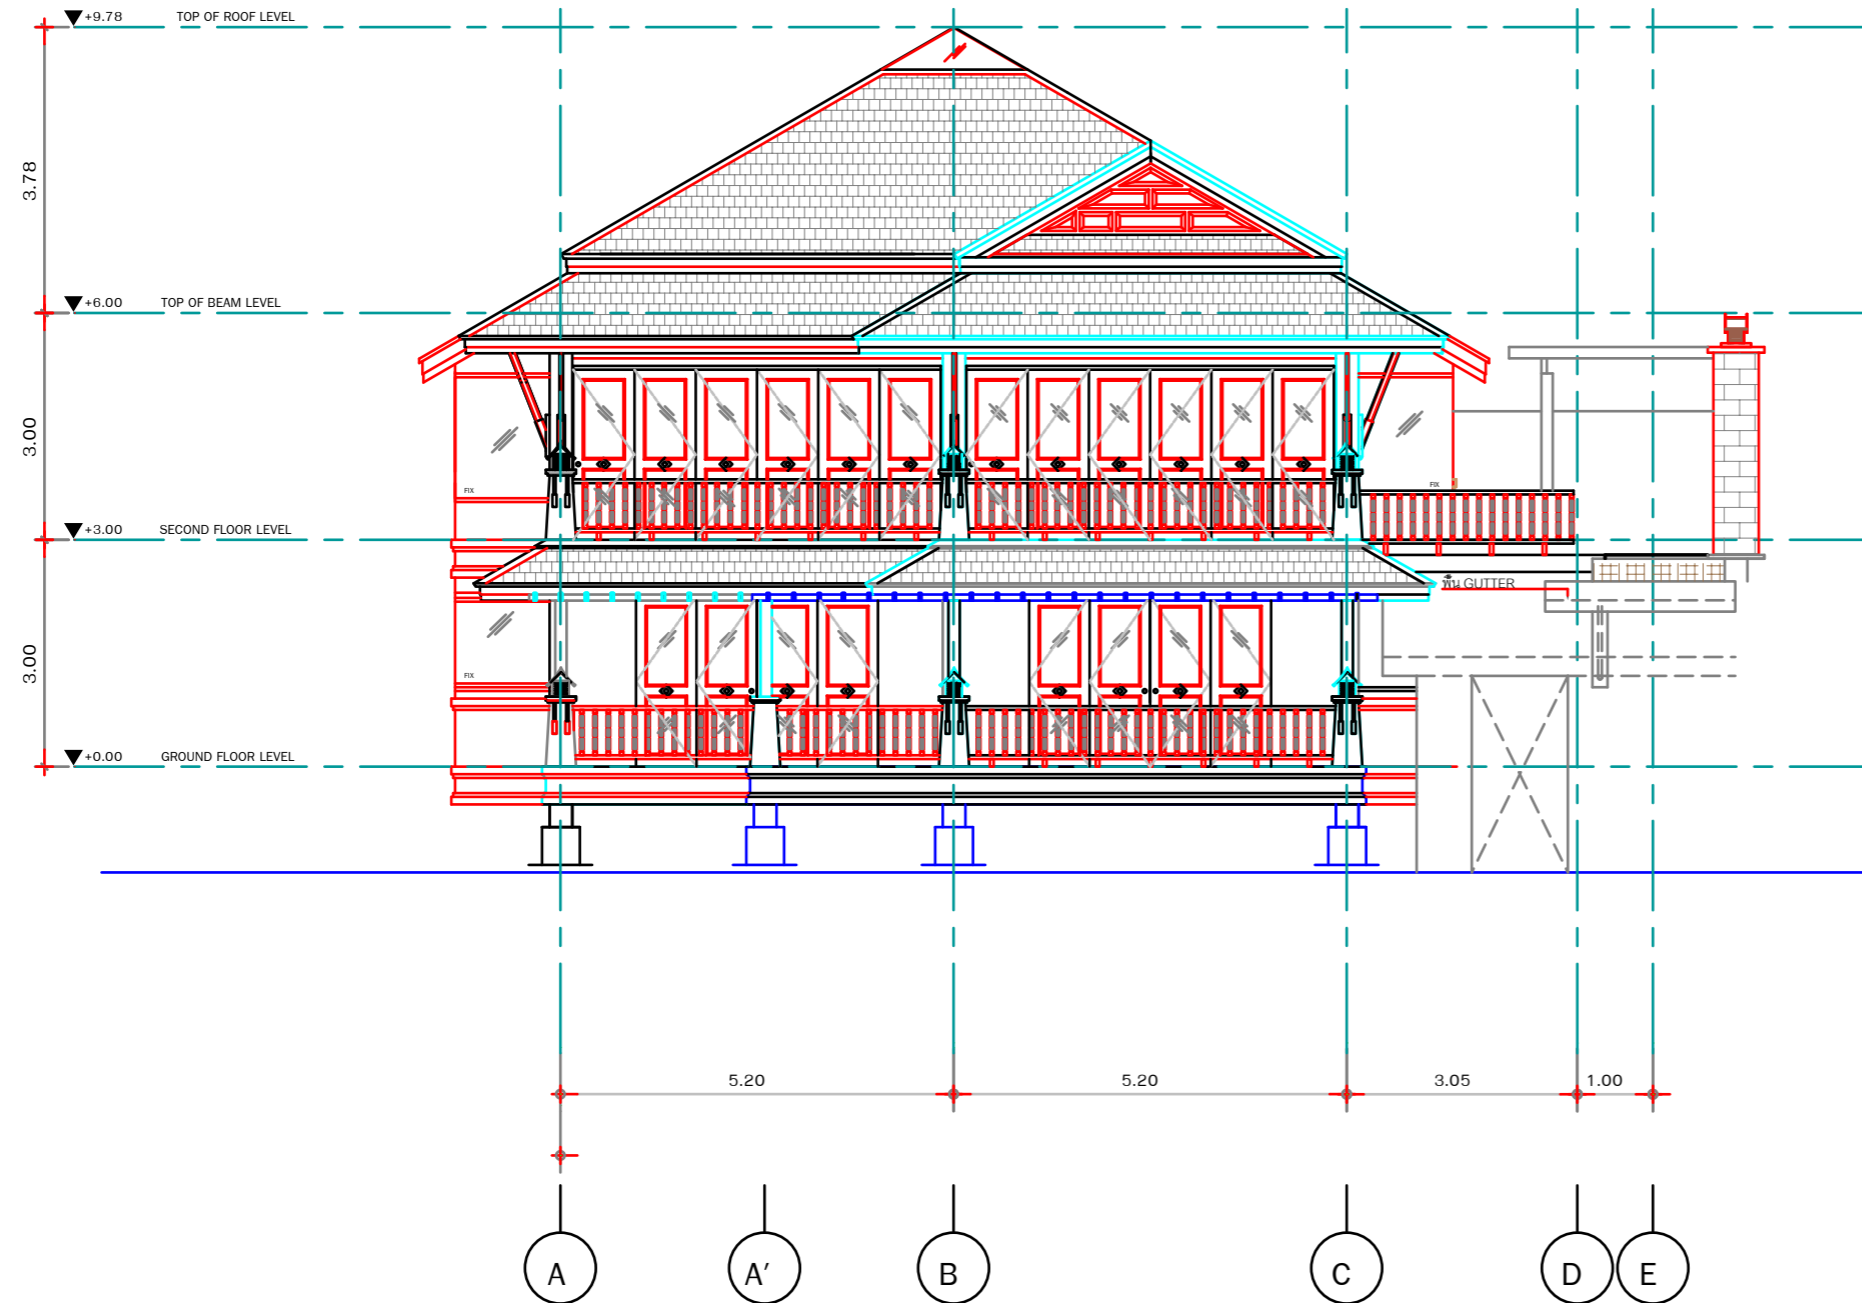

ELEVATION 1

SCALE 1 : 125



DRAWING

| | | |
|--|--|--|
| | | |
| | | |
| | | |
| | | |
| | | |
| | | |
| | | |
| | | |

REVISIONS

GENERAL NOTE


| | |
|--|--|
| | |
| | |
| | |

Drawing title :

ELEVATION 2

TYPE B1/B2

| | | | |
|---------------|--------------|---------|--|
| CHECK BY : | J. PHEERAWAT | DWG.NO. | |
| DWG BY : | R. JARUG | | |
| DATE : | 25-06-05 | | |
| SCALE : | 1:125 | | |
| APPROVED BY : | | TOTAL | |
| FILE NAME : | | | |

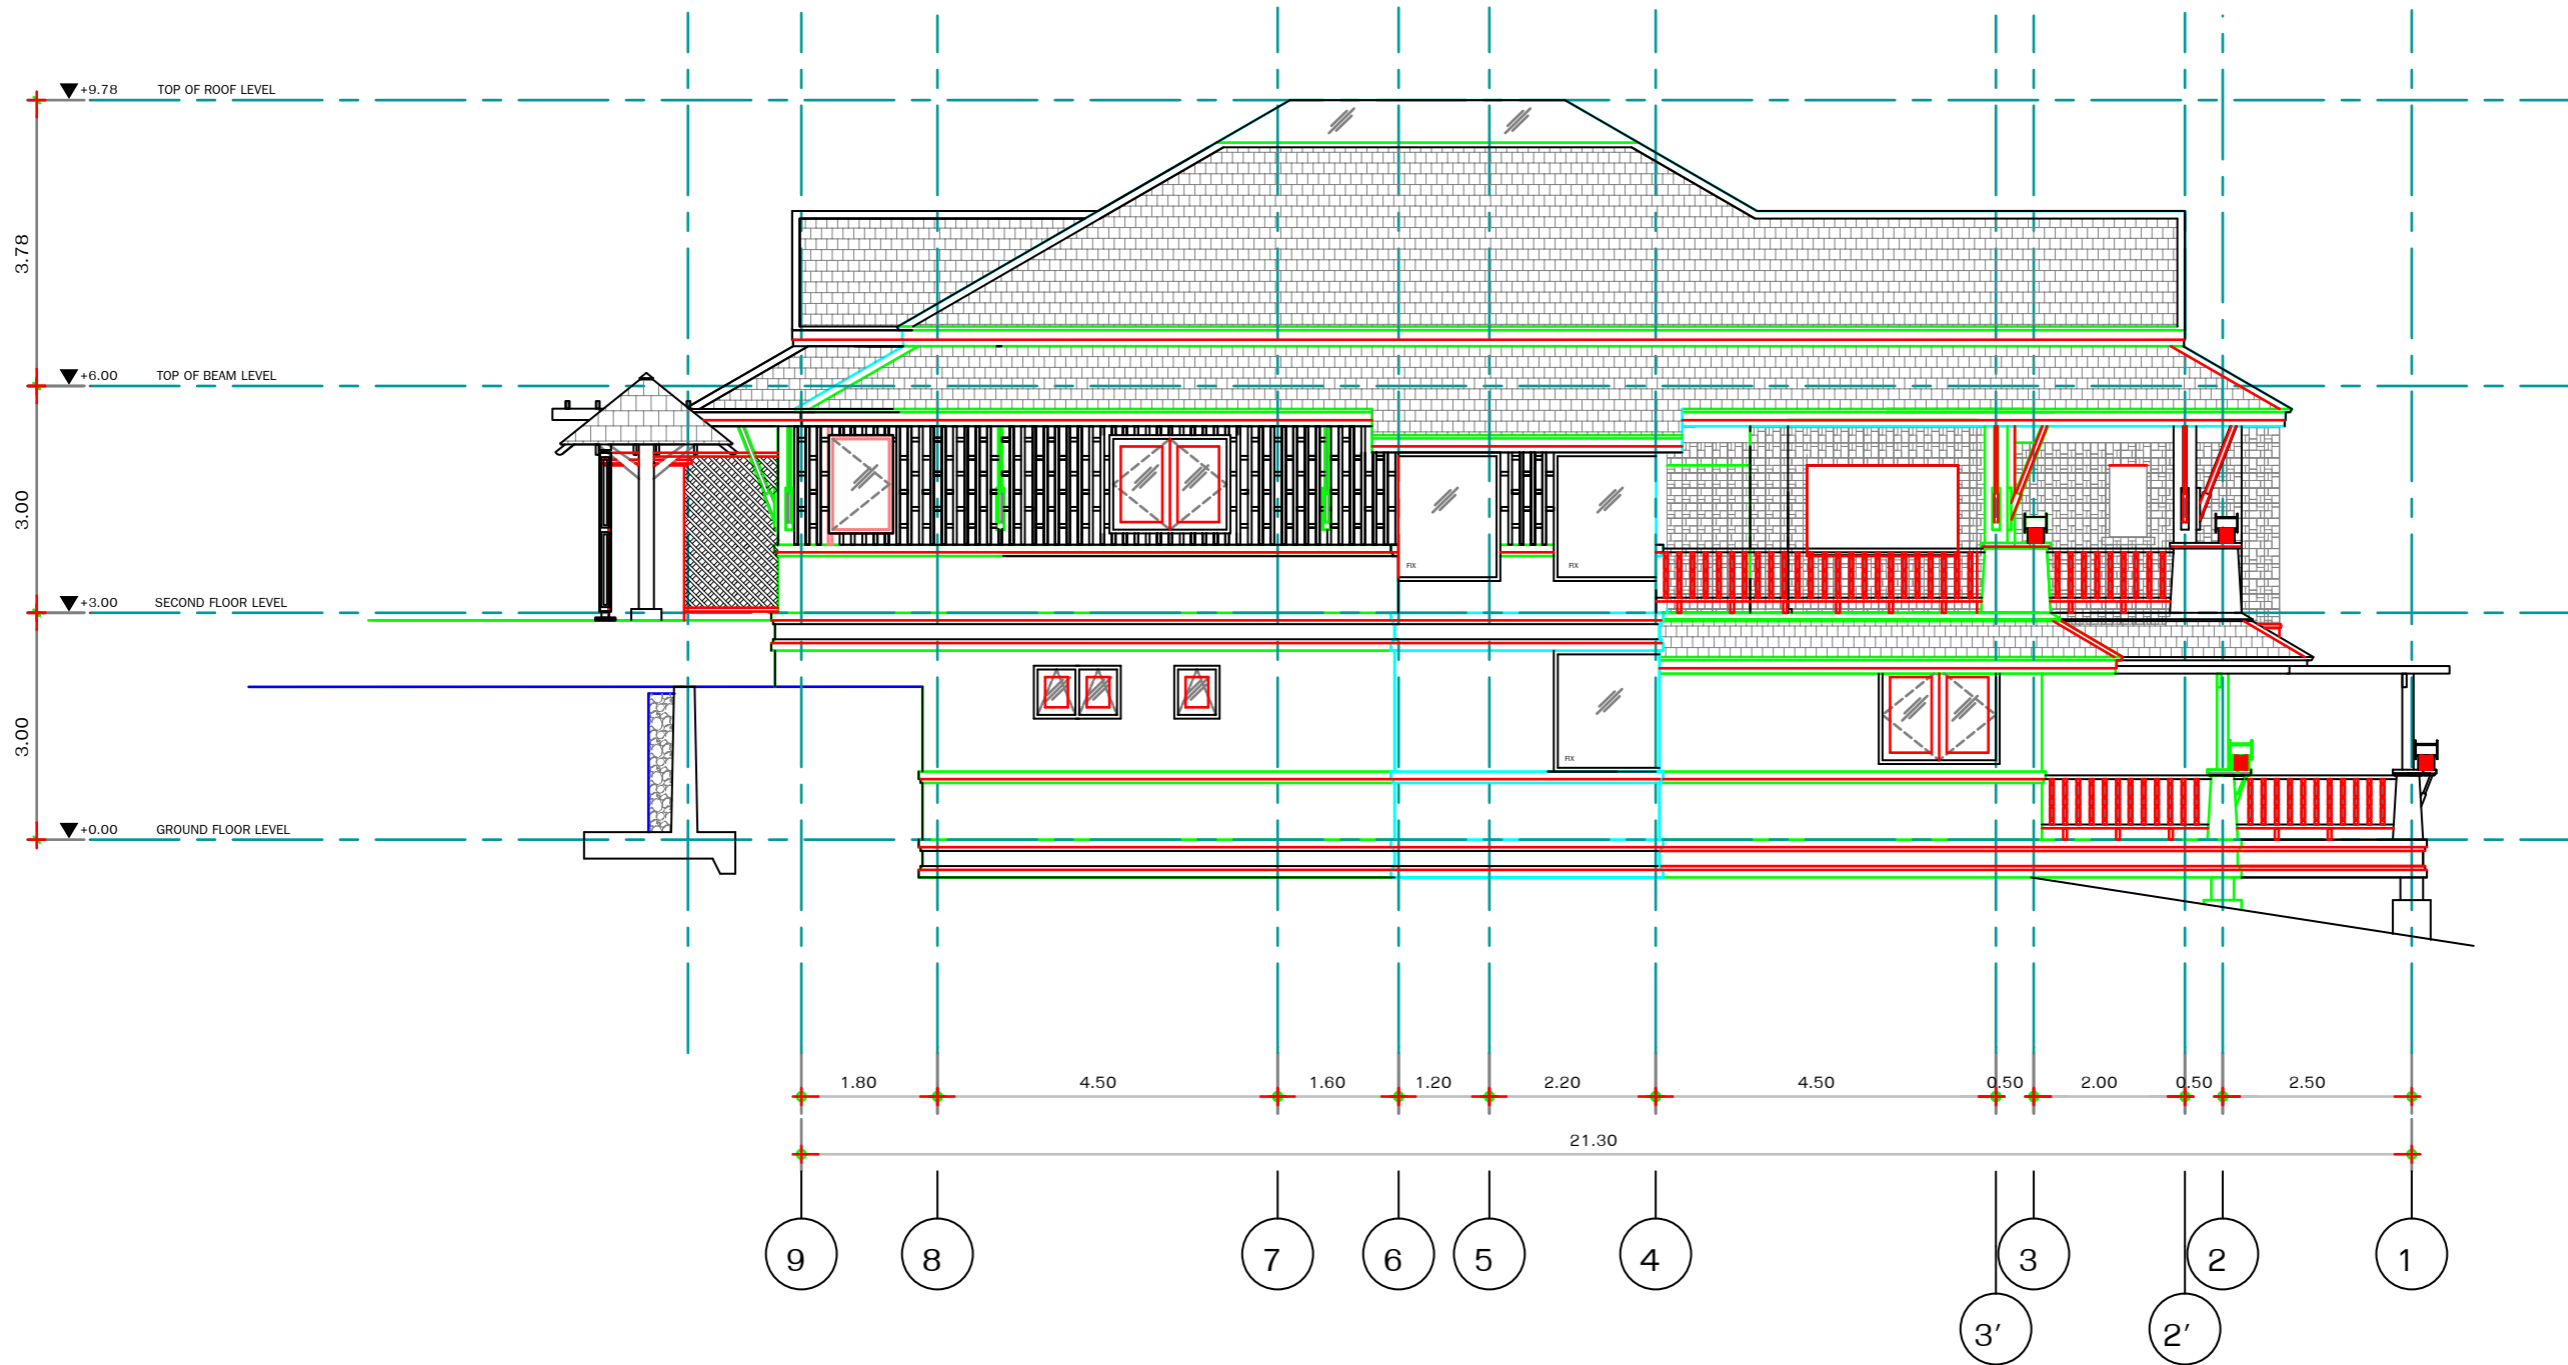

ELEVATION 2

SCALE 1 : 125

L'ORCHIDEE RESIDENCES

Location :
PATONG , PHUKET


Building :
VILLA TYPE B2

Owner :



A.C. HIGHLAND CO.,LTD.

APPROVED BY :
MAIN CONTRACTOR :



POWER LINE
POWER LINE ENGINEERING PUBLIC CO., LTD.

Architect/Designer :

Structural Engineers :


Electrical Engineers :

Mechanical Engineers :

Sanitary Engineers :

Landscape Architect :

Interior Designer :

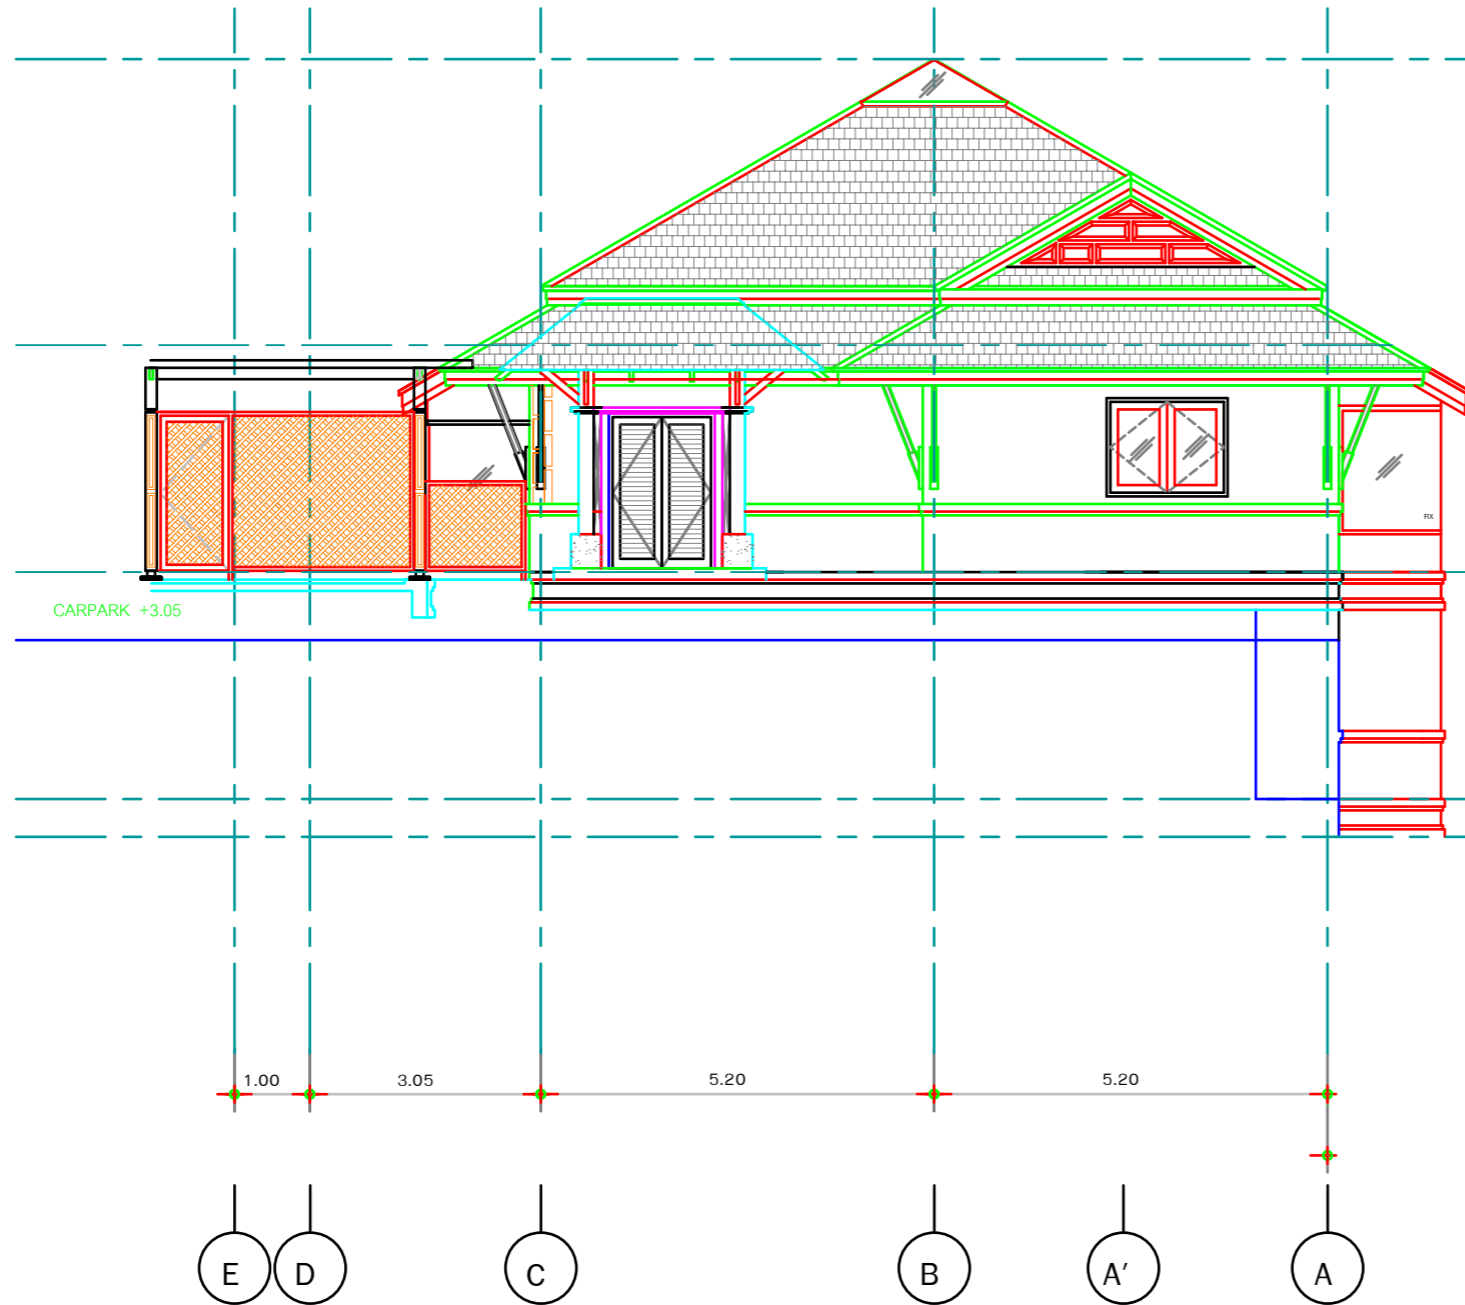

ELEVATION 3

SCALE 1 : 125

DRAWING

| | | |
|--|--|--|
| | | |
| | | |
| | | |
| | | |
| | | |
| | | |

REVISIONS

GENERAL NOTE

Drawing title :

ELEVATION 3

TYPE B1/B2

| | | | |
|---------------|--------------|--------------|---|
| CHECK BY : | J. PHEERAWAT | DWG.NO. | |
| DWG BY : | R. JARUG | PLE-PTR-B1B2 | |
| DATE : | 25-06-05 | AR-006 | |
| SCALE : | 1:125 | TOTAL | |
| APPROVED BY : | - | FILE NAME : | - |